






--REAR ELEVATION - NORTH--

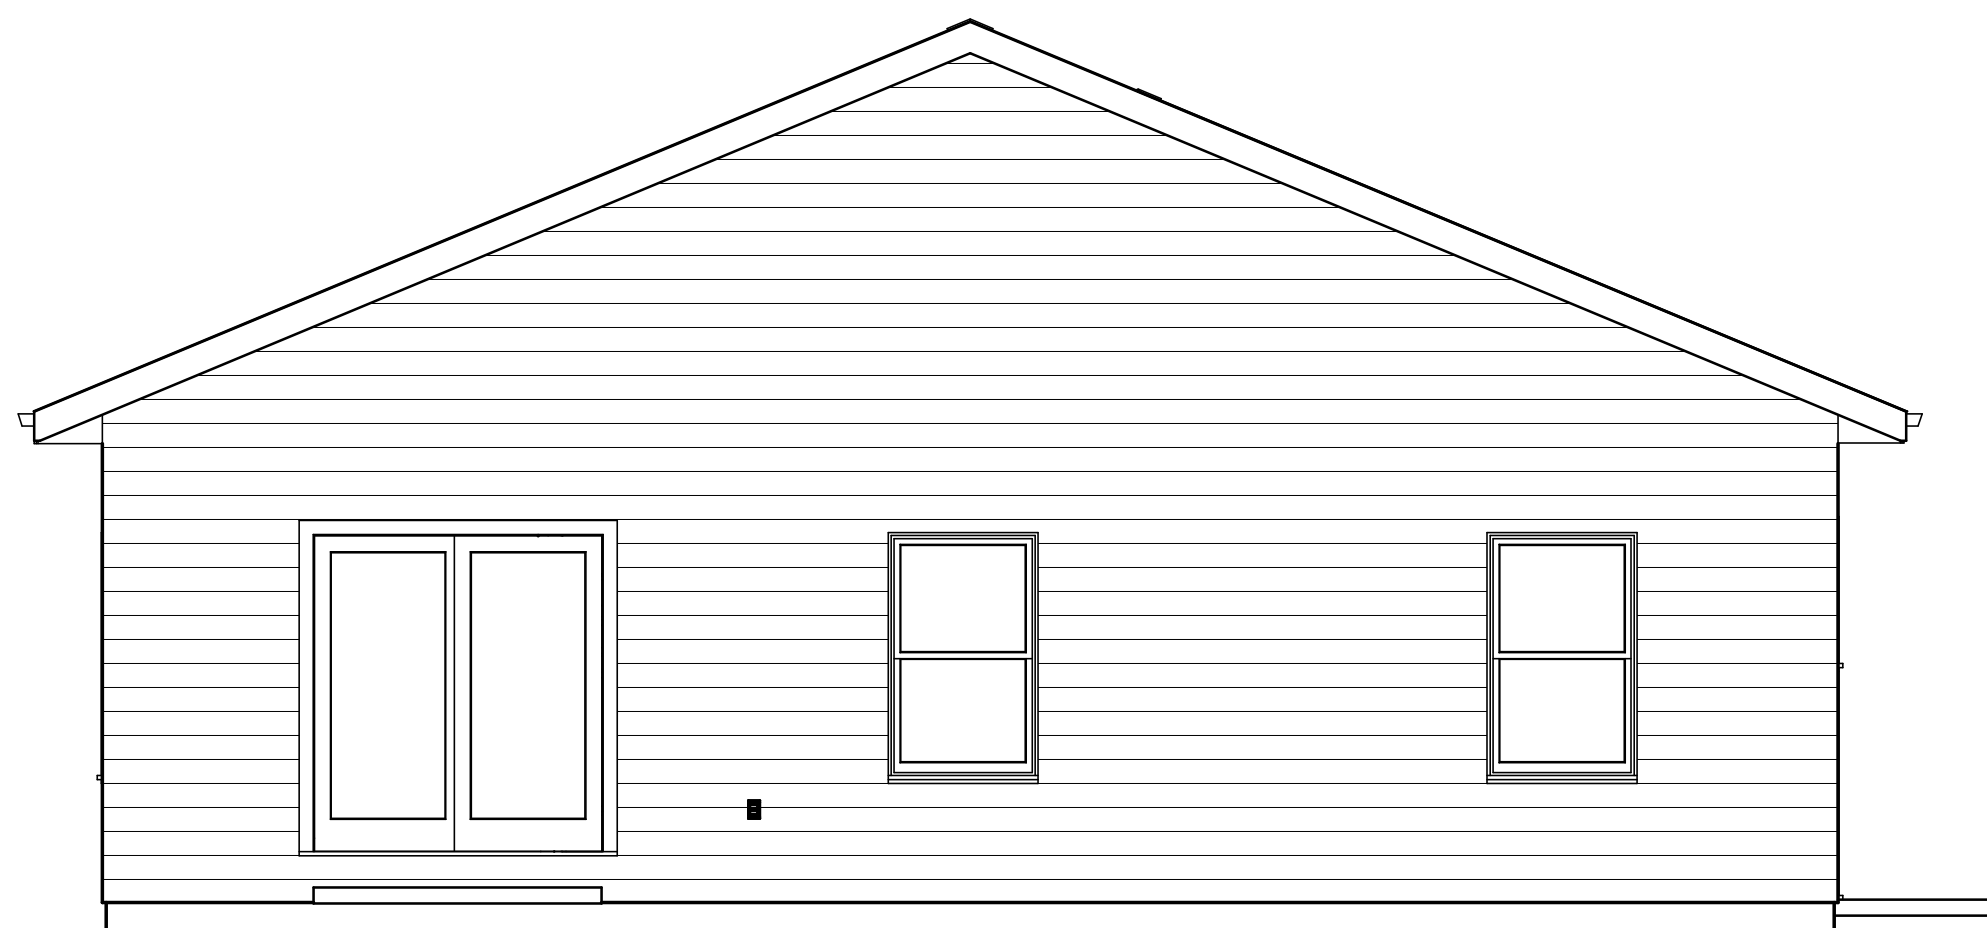

--LEFT ELEVATION--

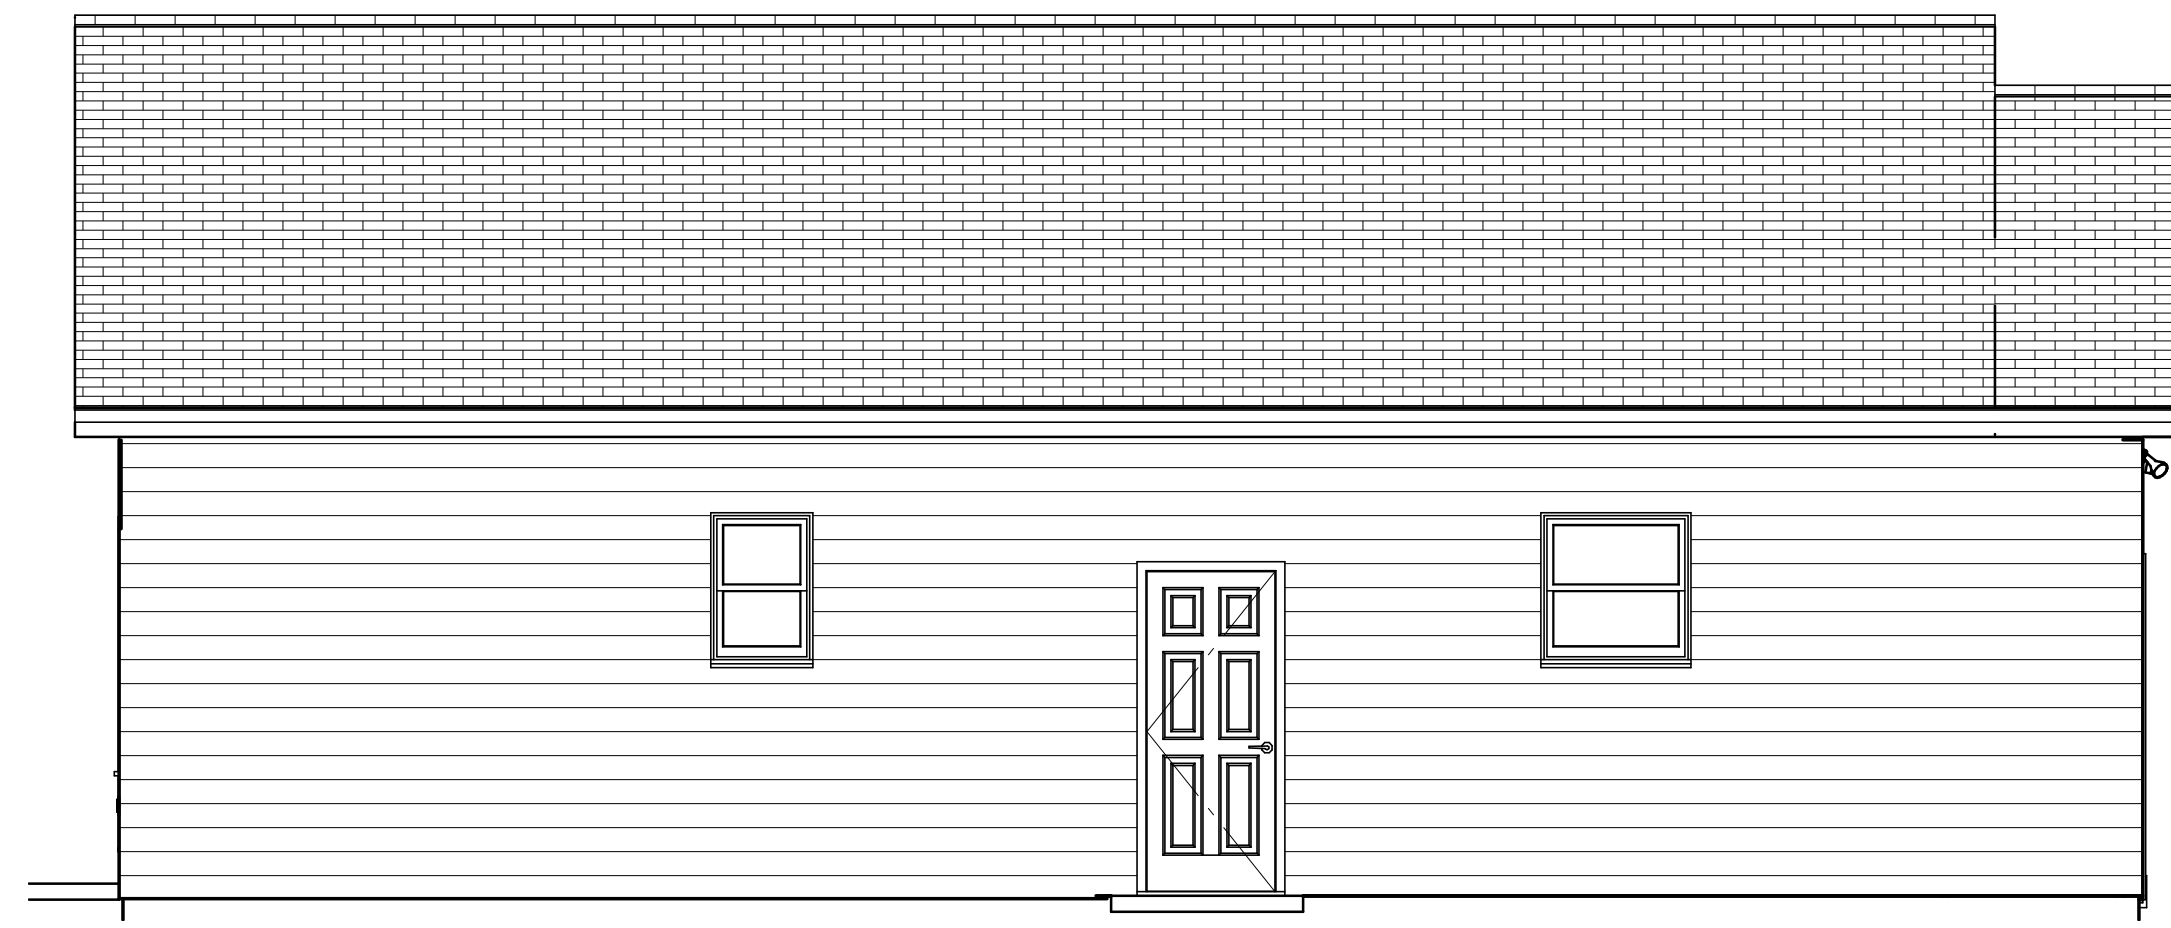

--FRONT ELEVATION--

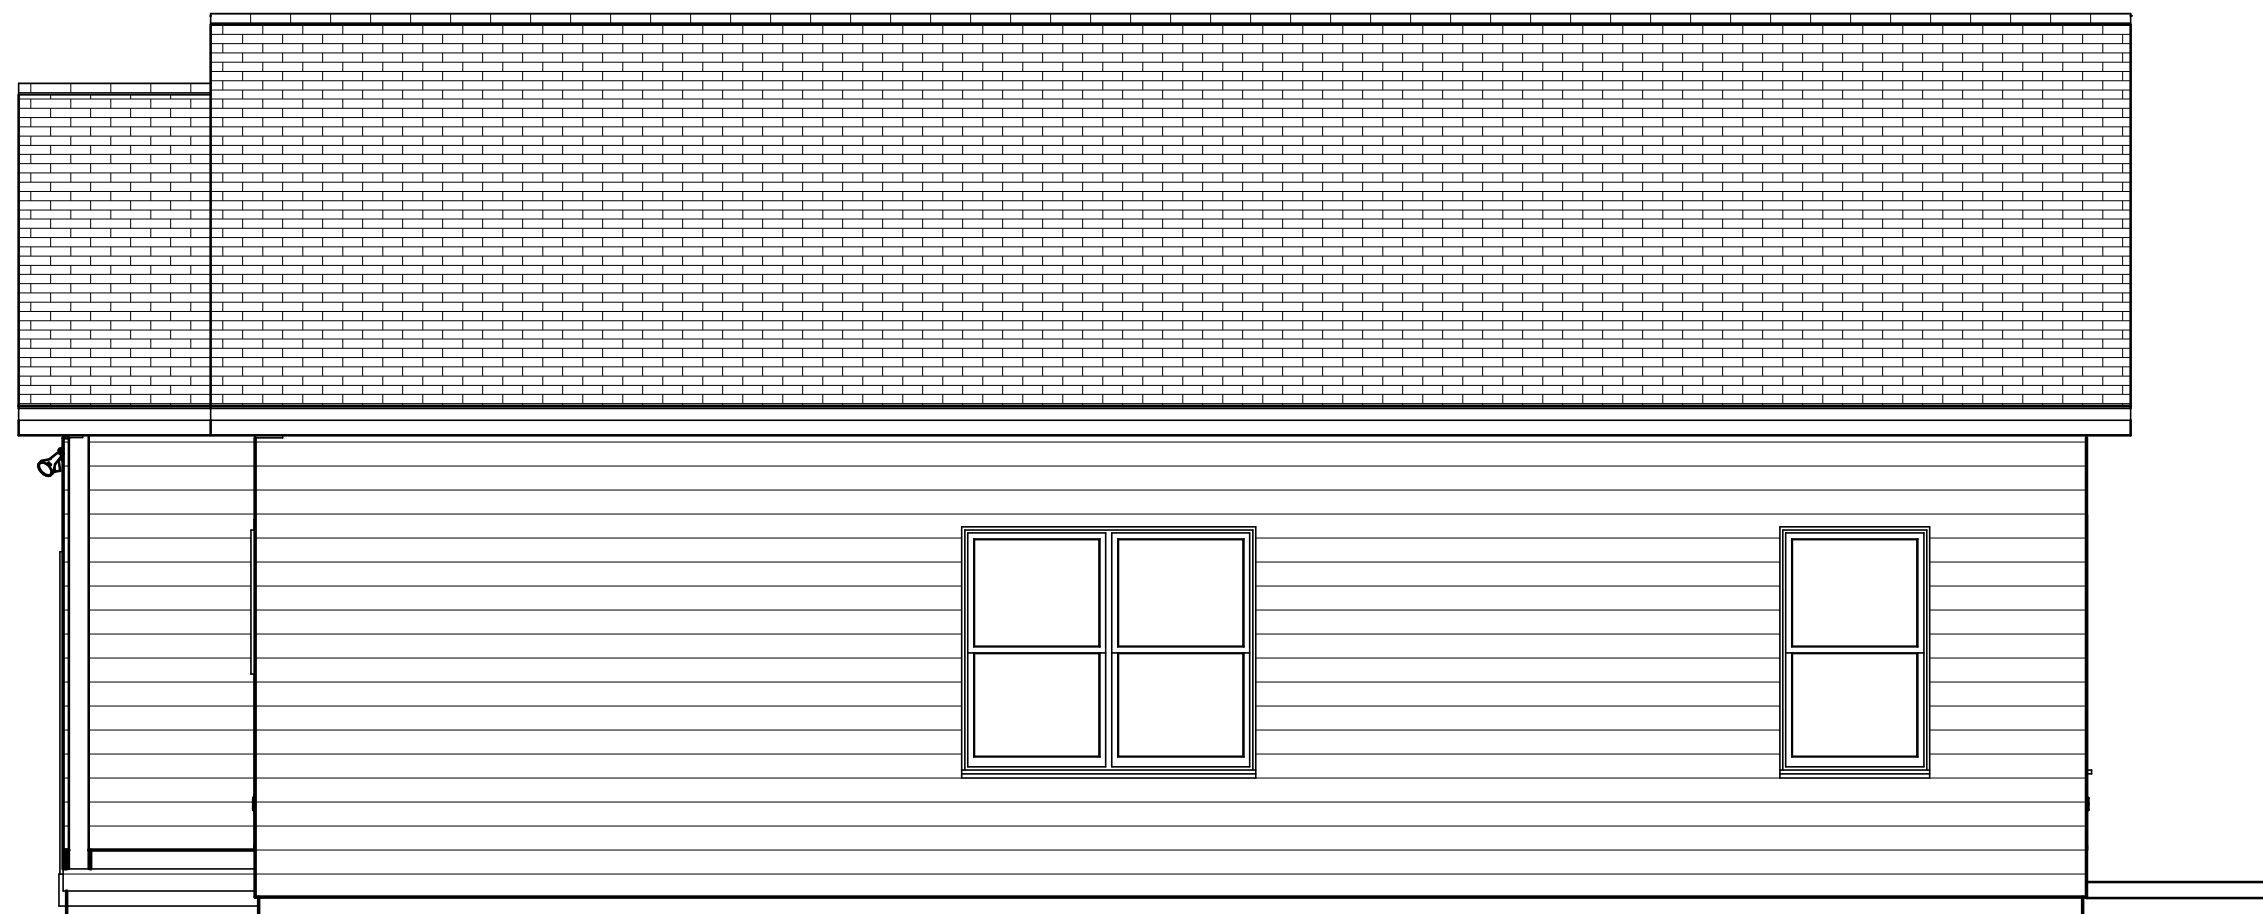


--RIGHT ELEVATION--


NOTE: WALL BRACING SHOWN ON PAGE 2 (INTERMITTENT & CONTINUOUS METHOD USED)
EROSION CONTROL SHOWN ON PAGE 6



FIRST FLOOR AREA: 983 SQ FT
TOTAL LIVING AREA: 1470 SQ FT

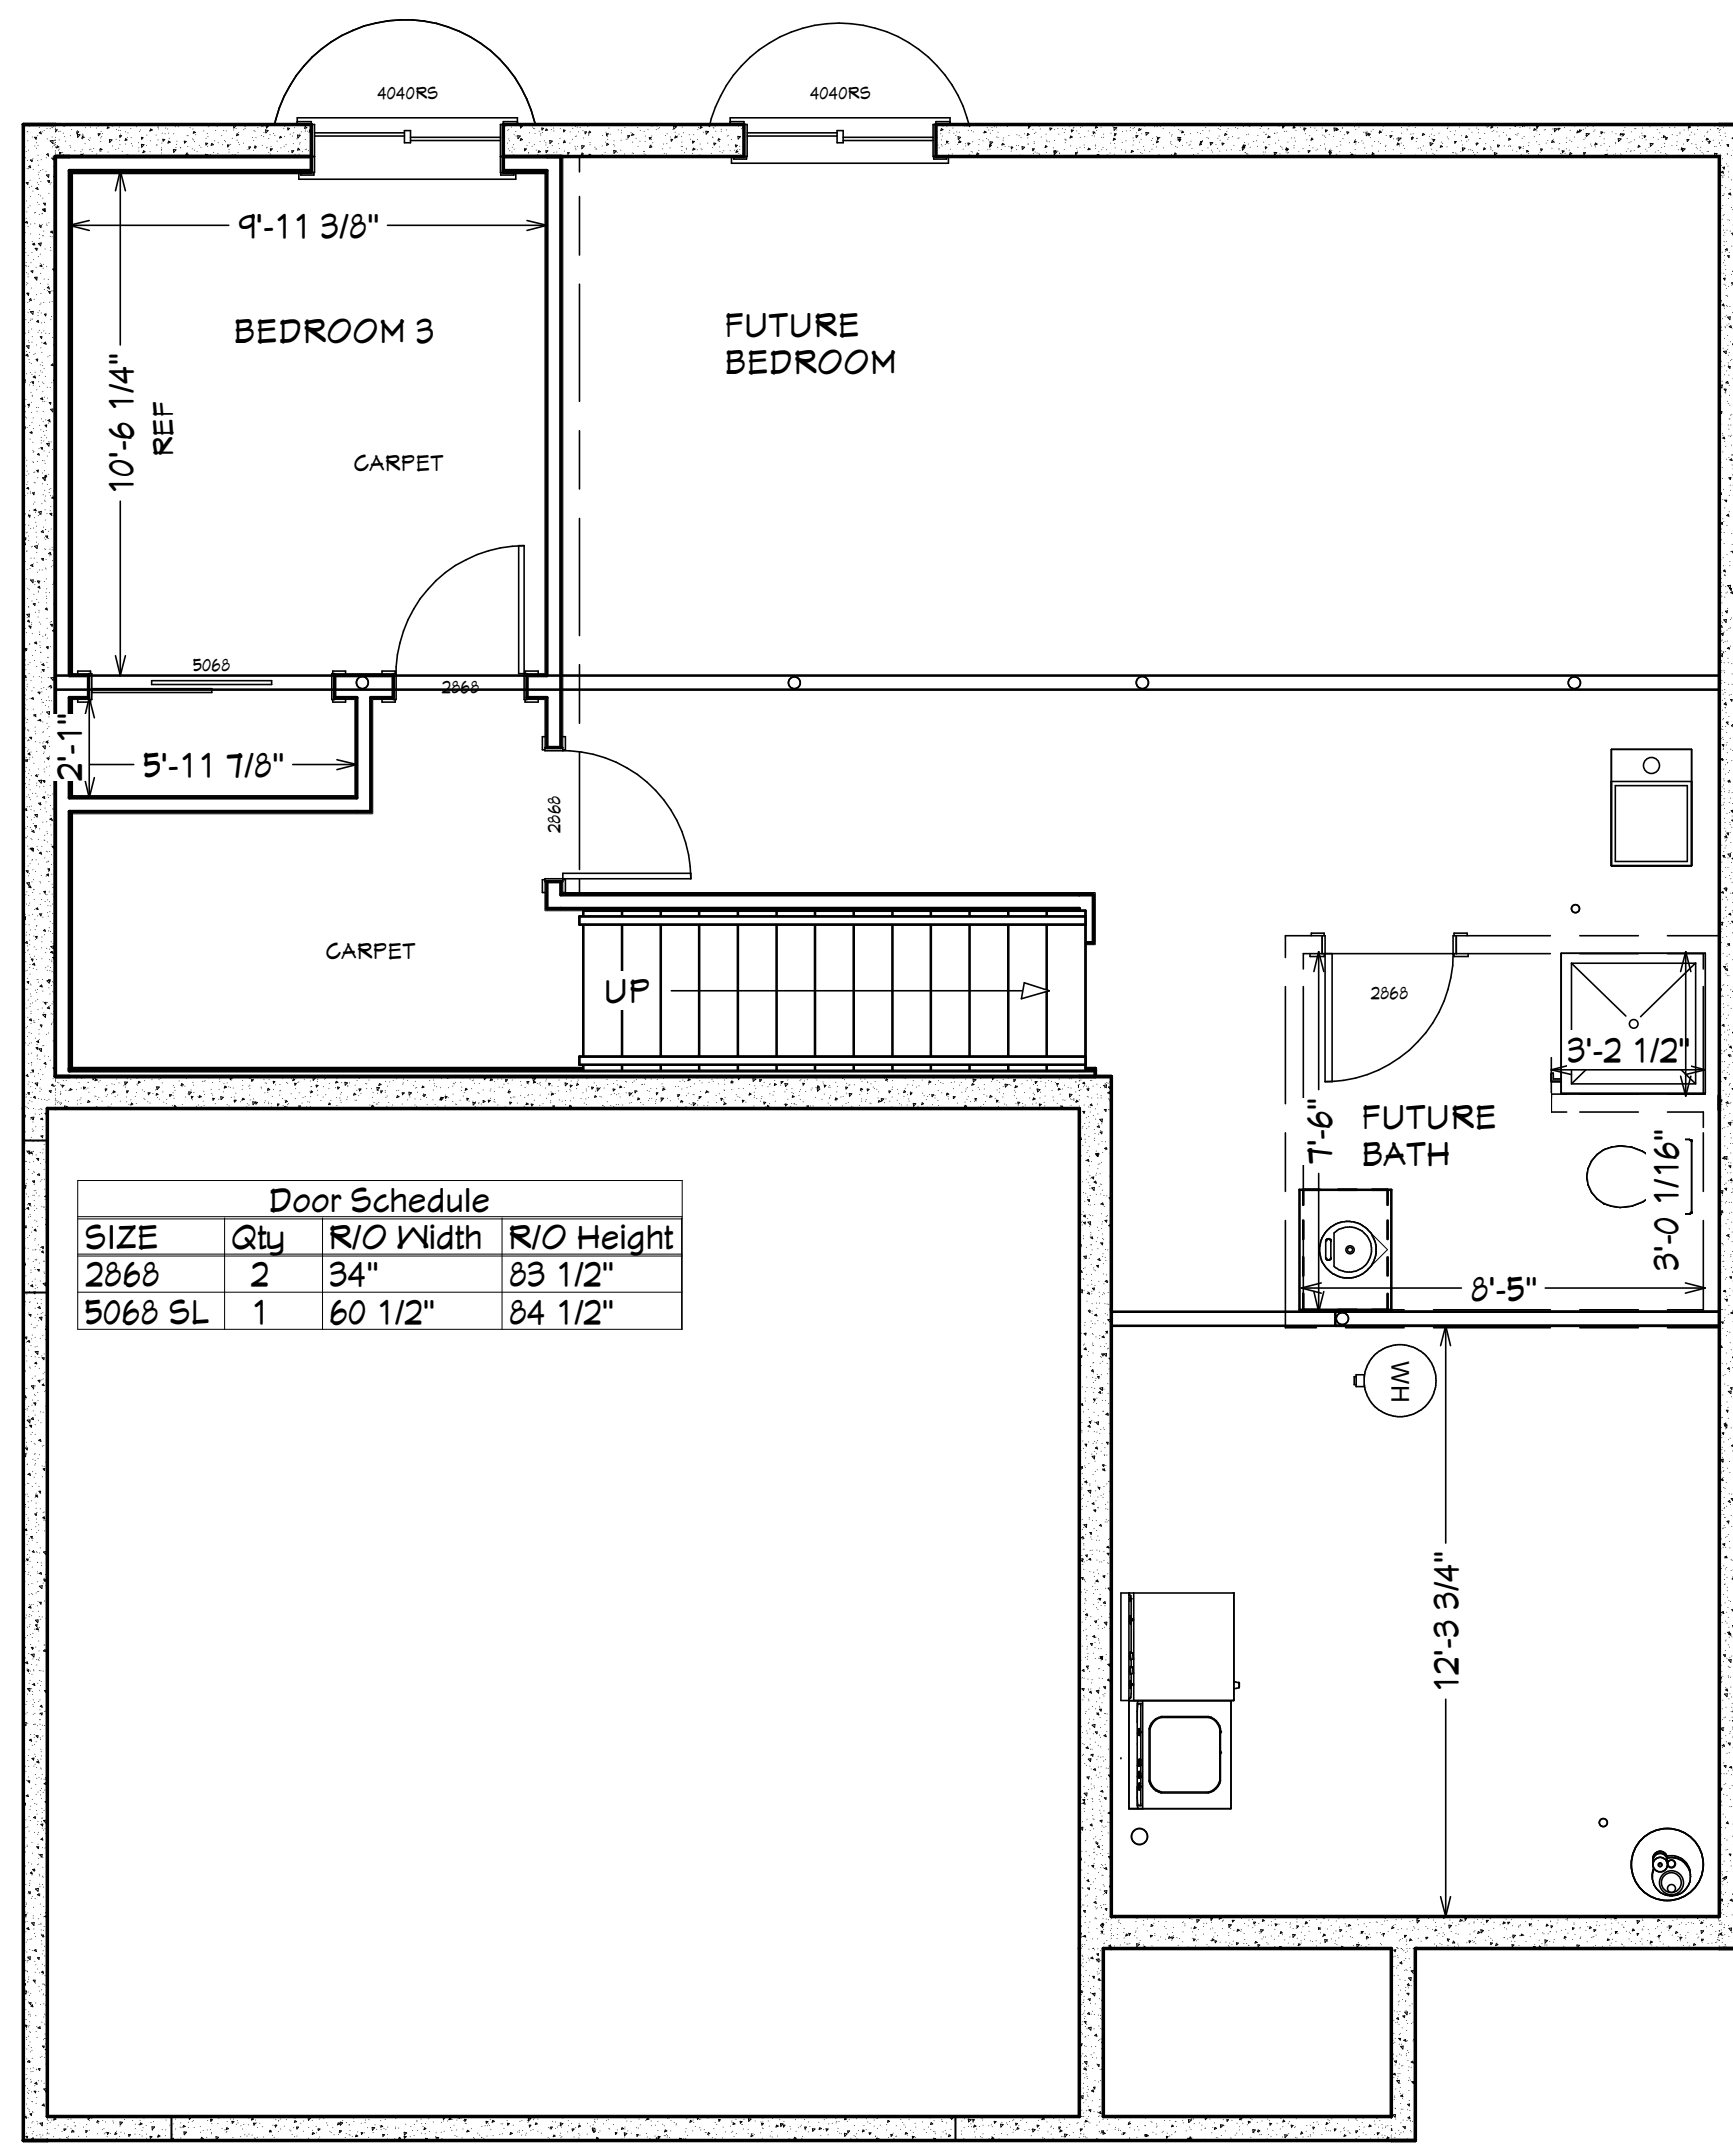


--BASEMENT PLAN--

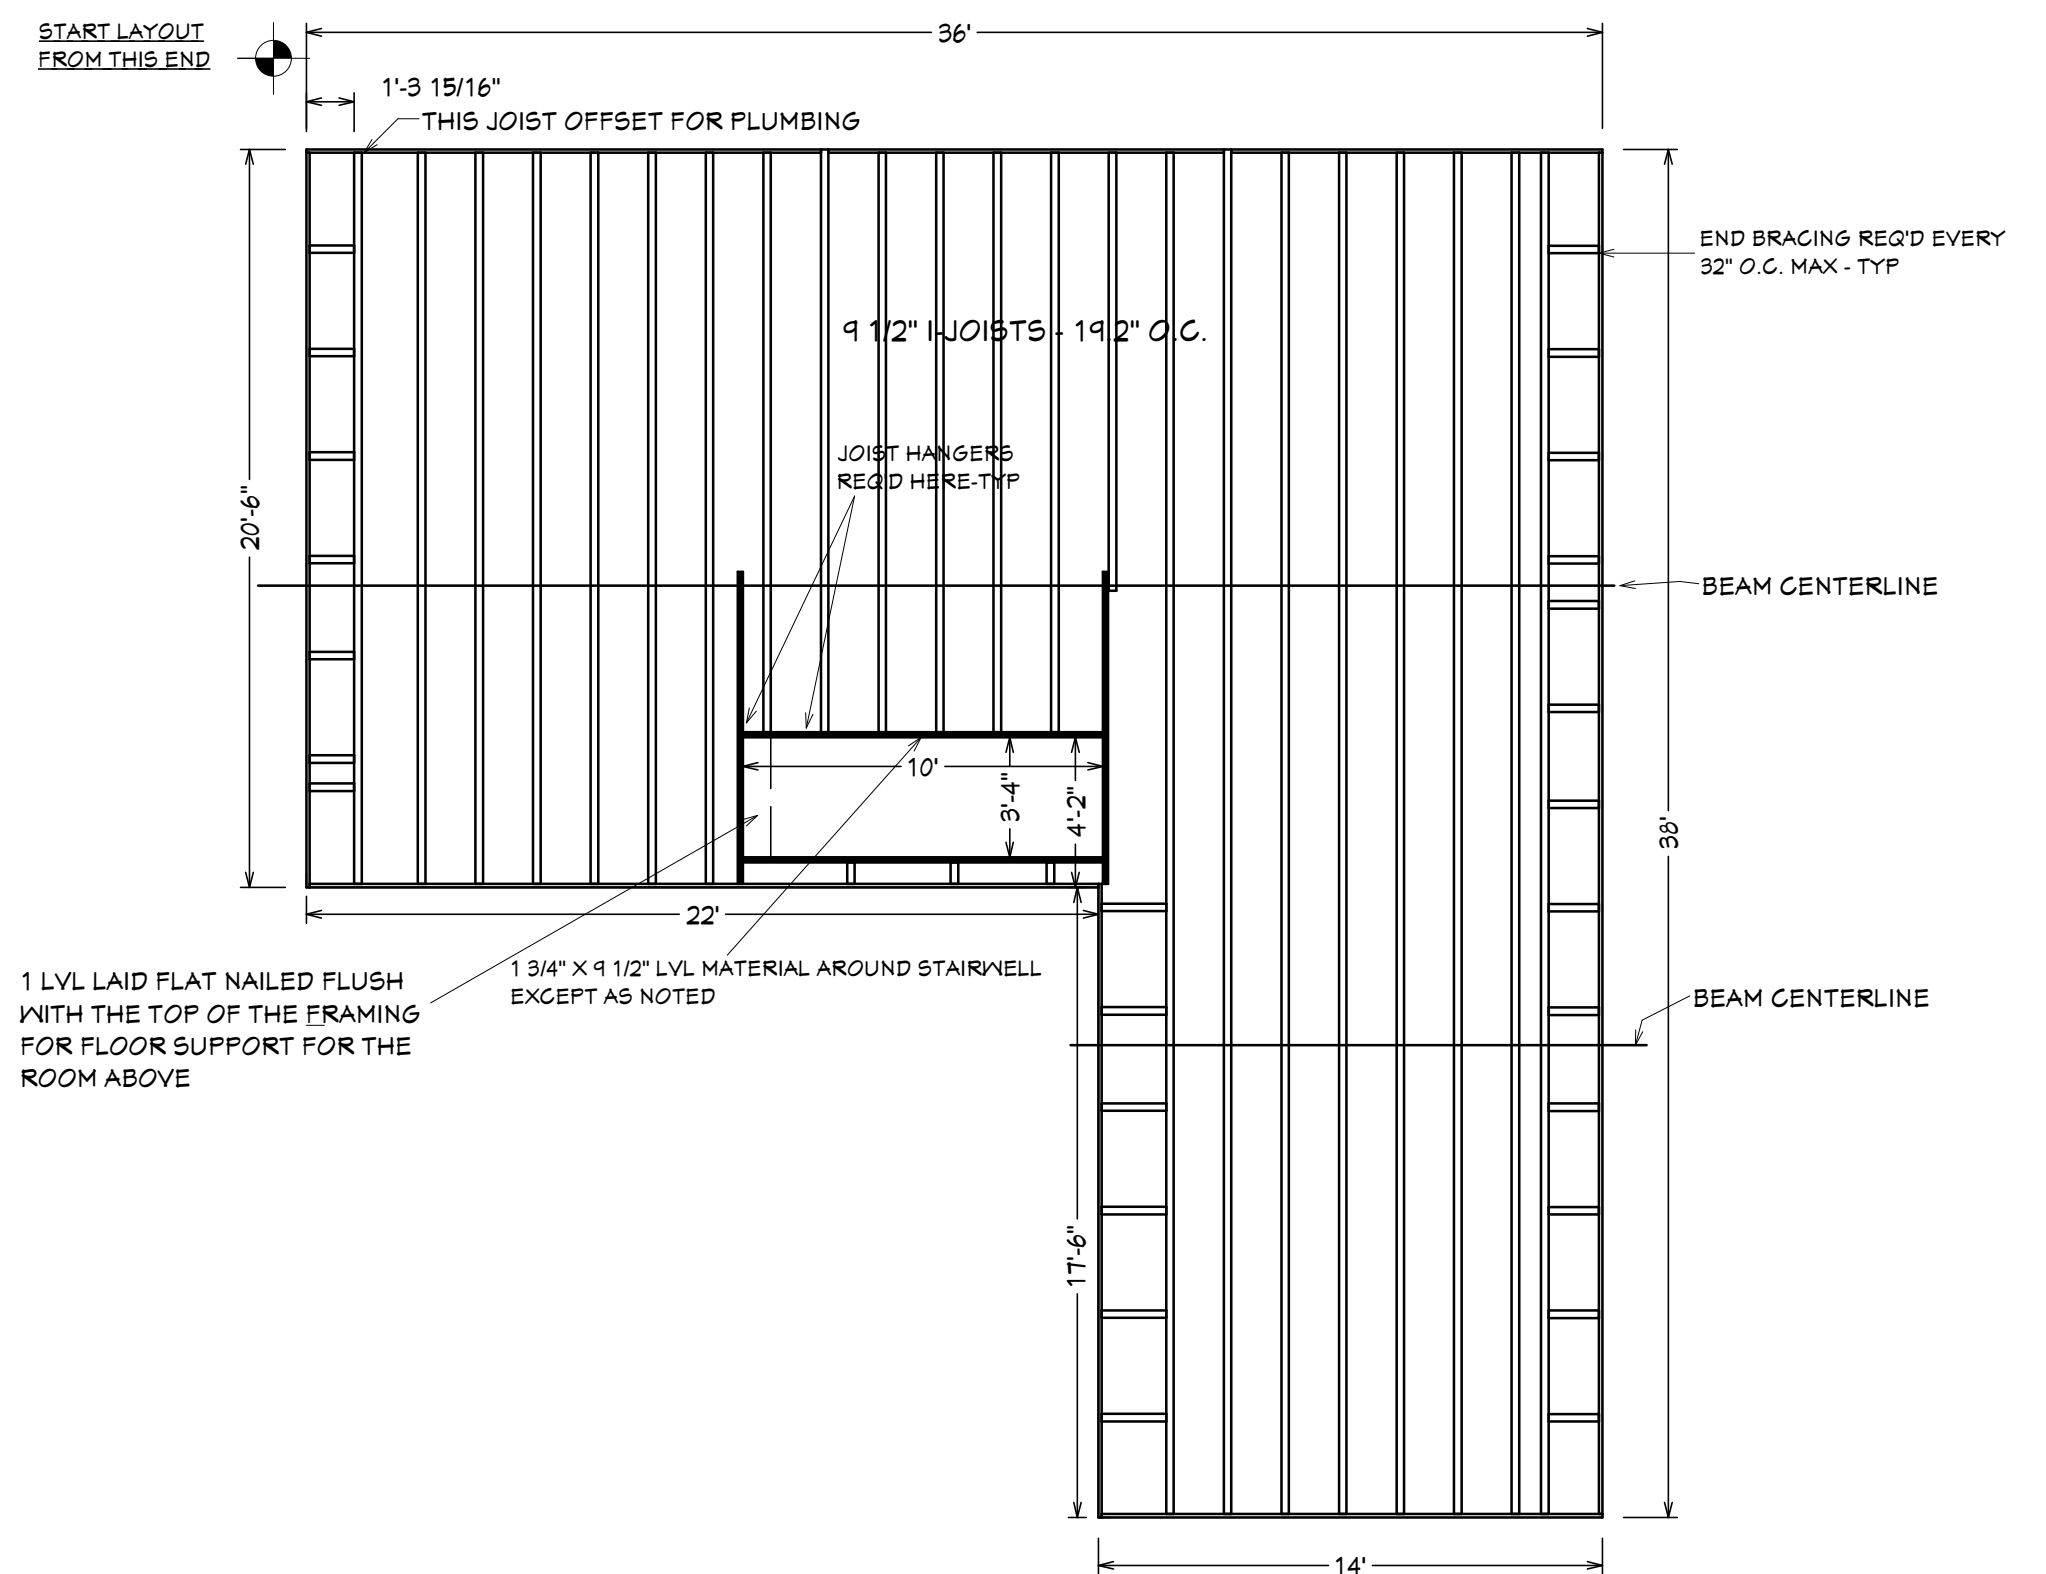

--FLOOR JOIST LAYOUT--

SCALE: 3/16" = 1'

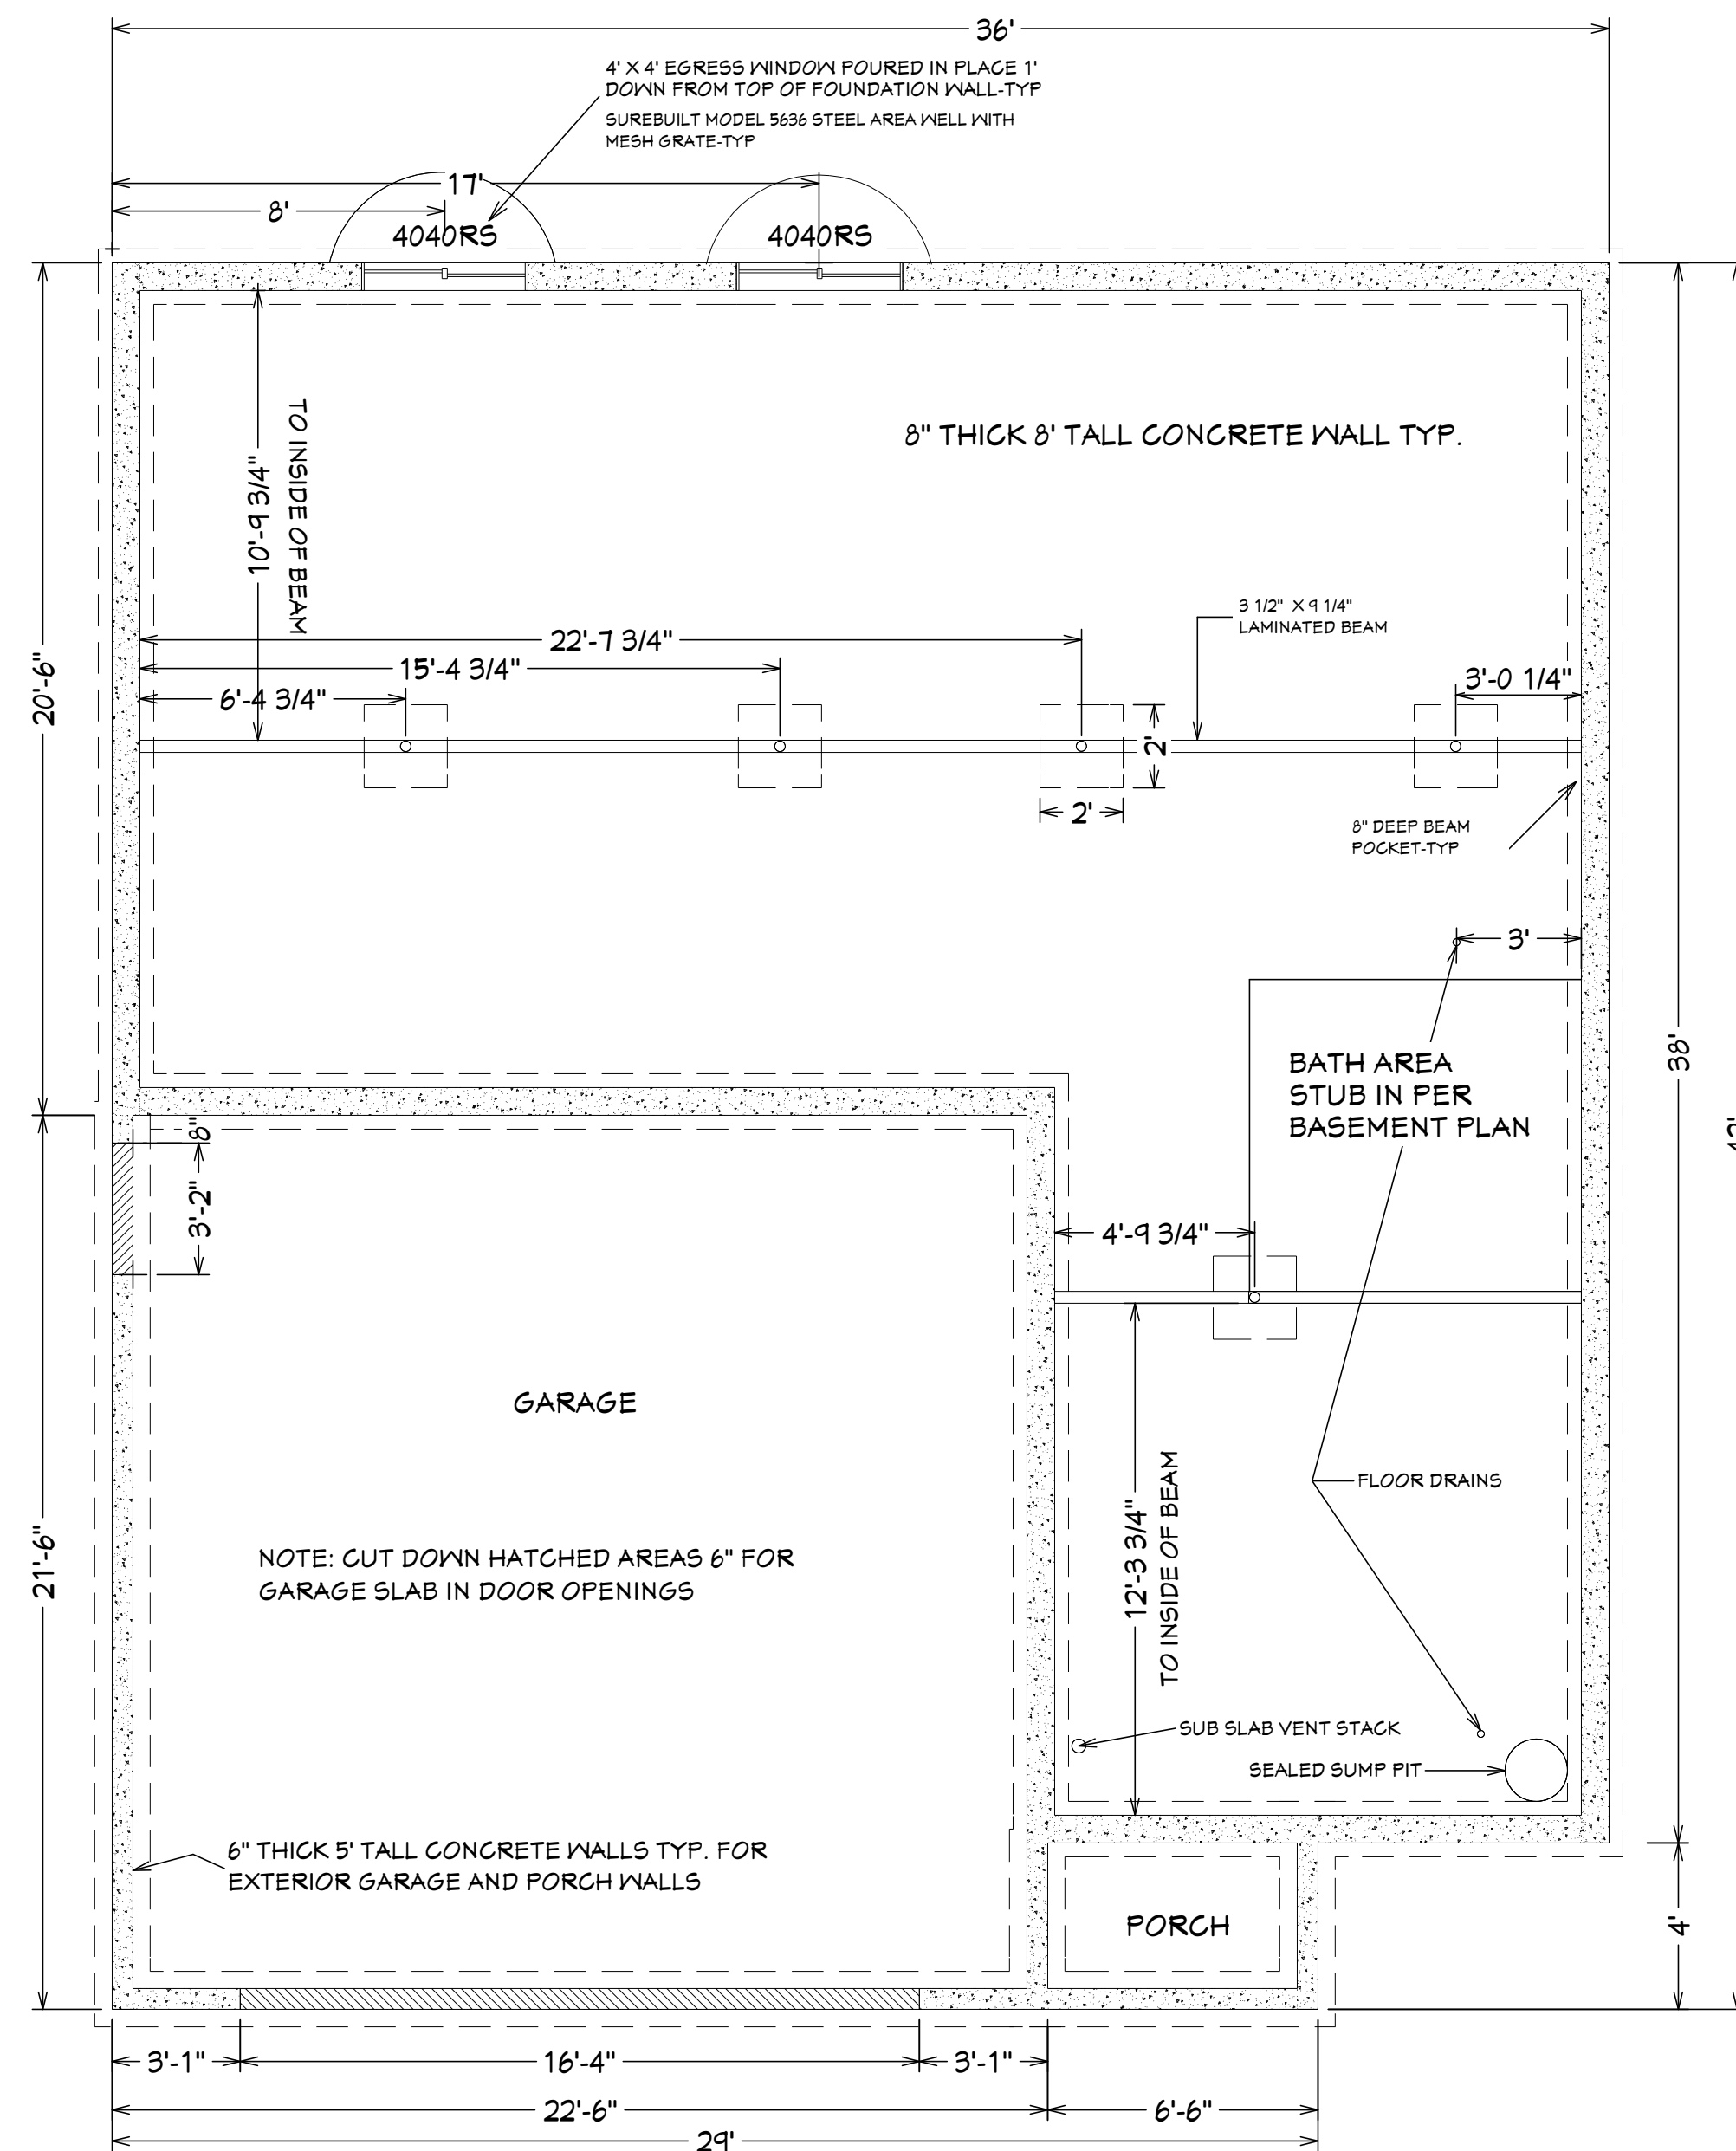

--FOUNDATION PLAN--

--STAIR DETAIL--

104" RISE

126 3/4" RUN

RISER HEIGHT 7 7/16"


OF RISES- 14

TREAD DEPTH 9 3/4"

OF TREADS- 13


N



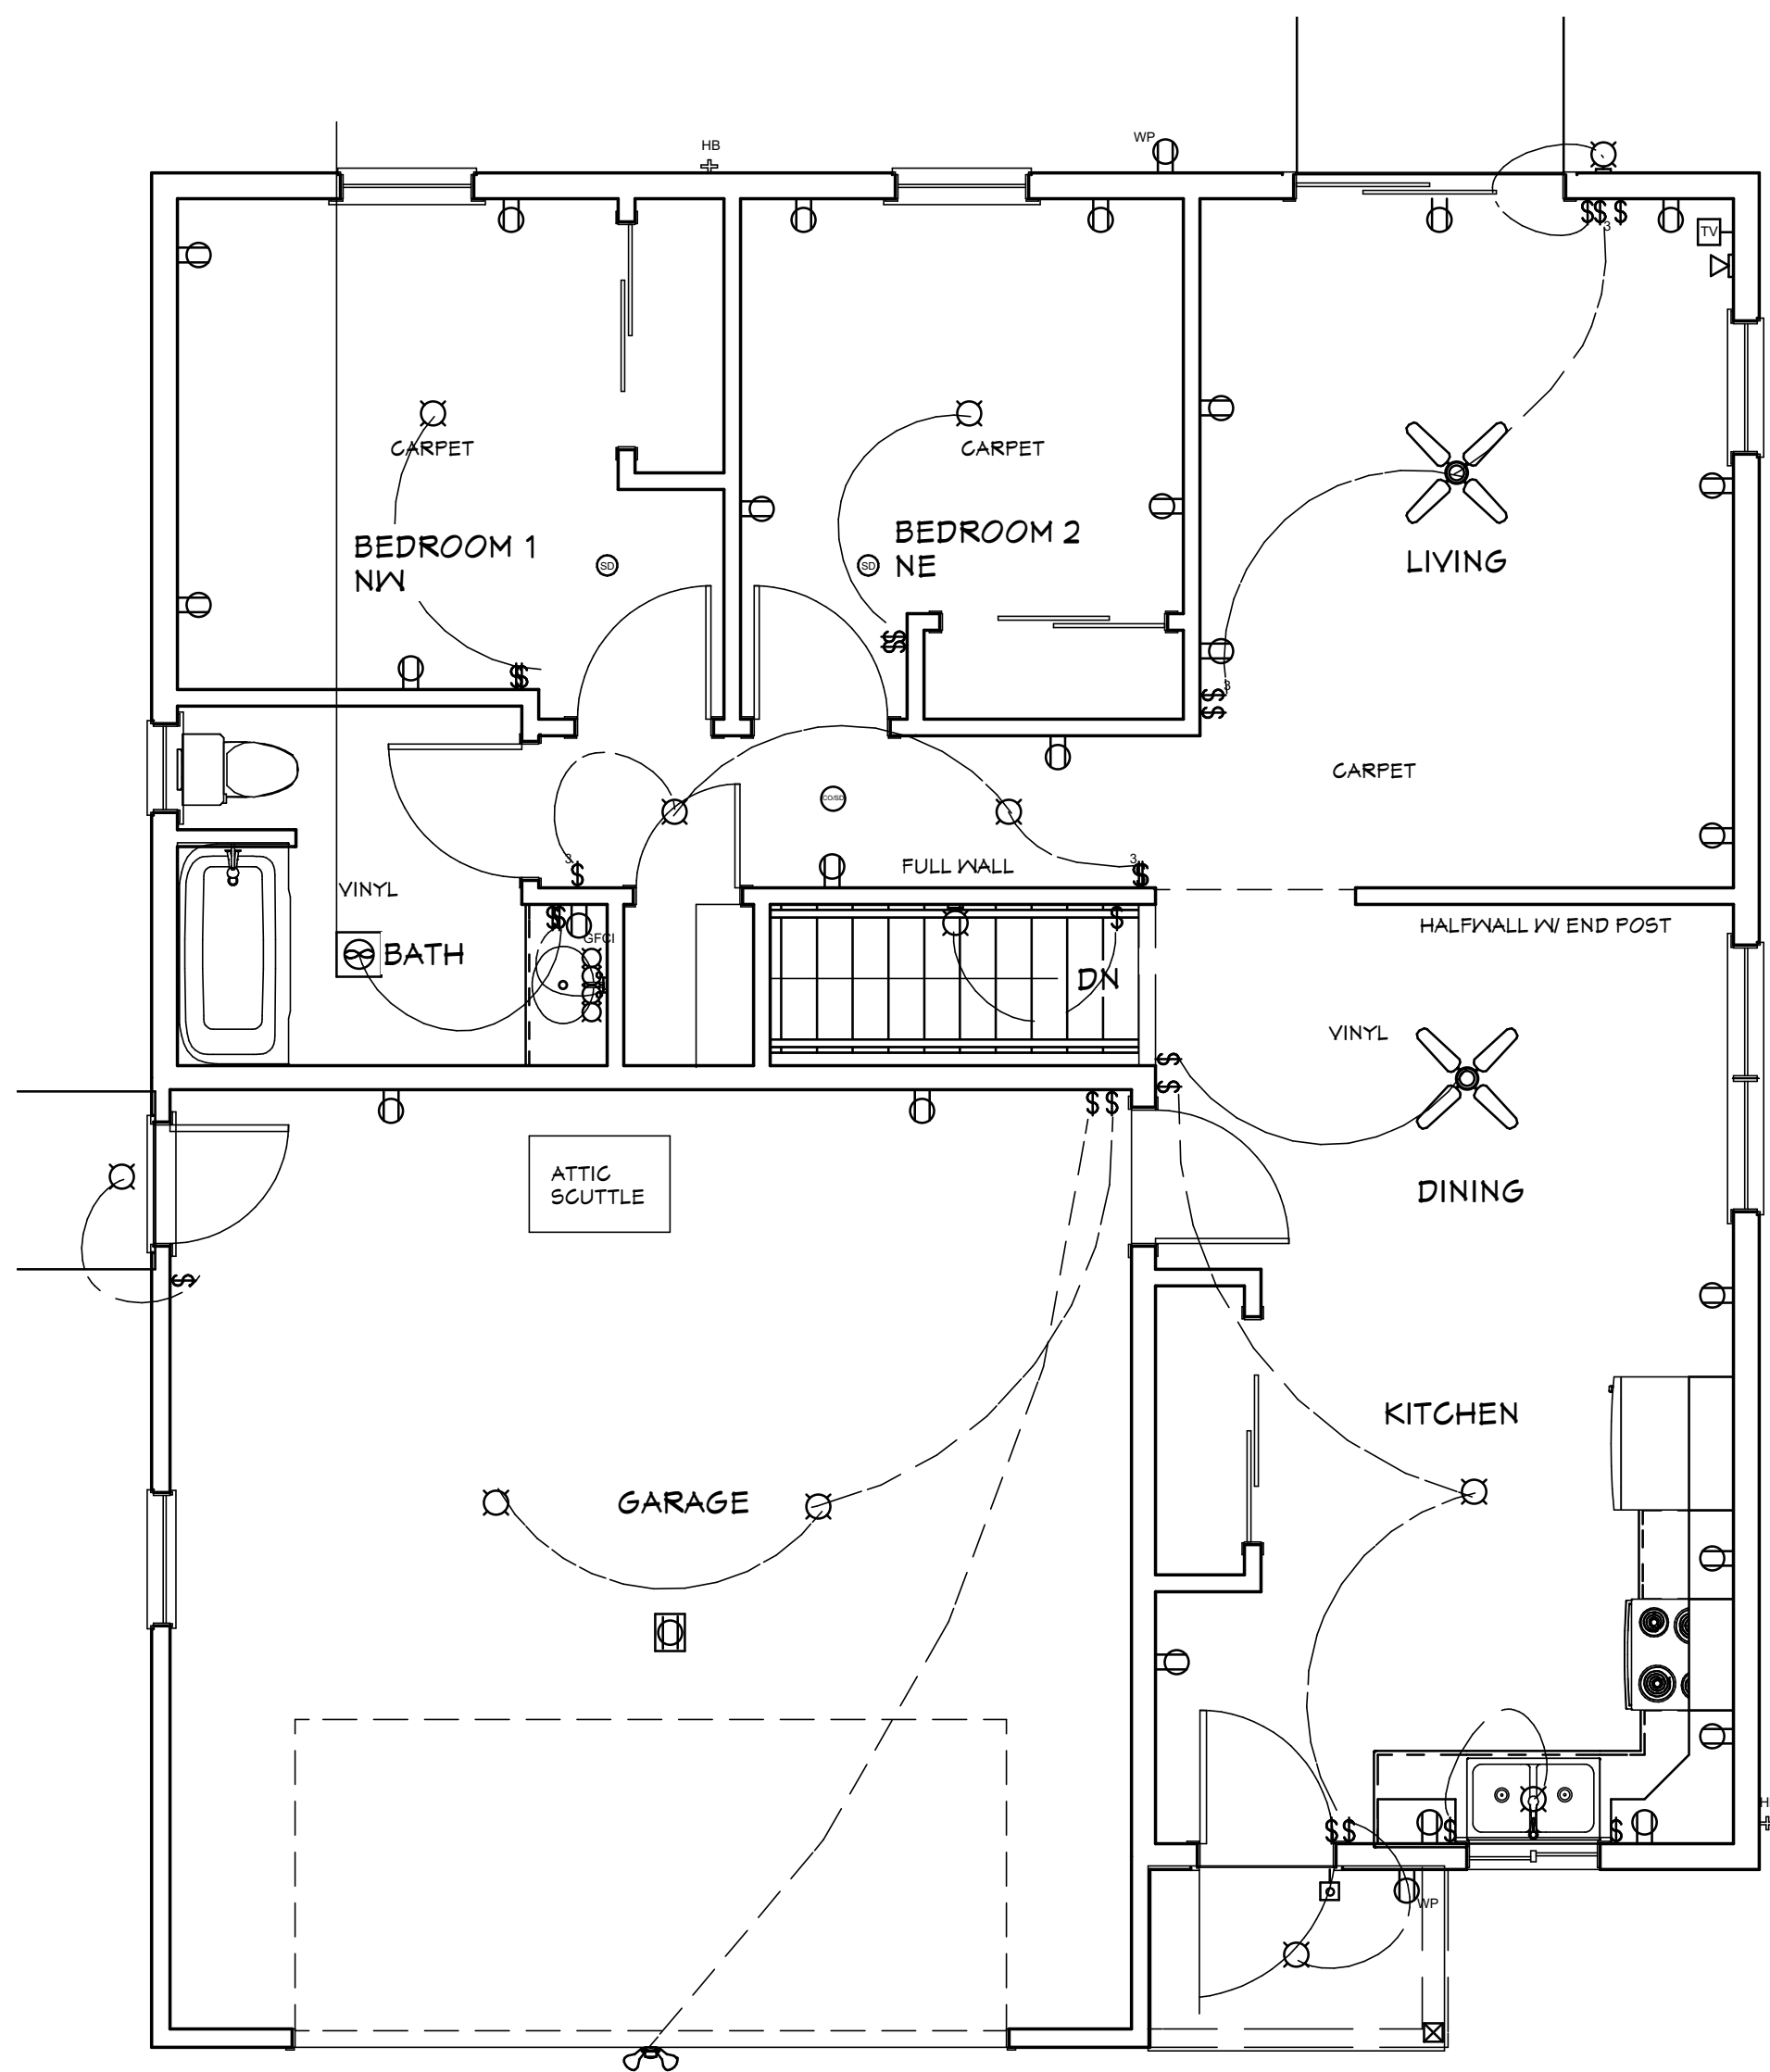

--FIRST FLOOR--


--OPTIONS LIST--
ELECTRIC STOVE

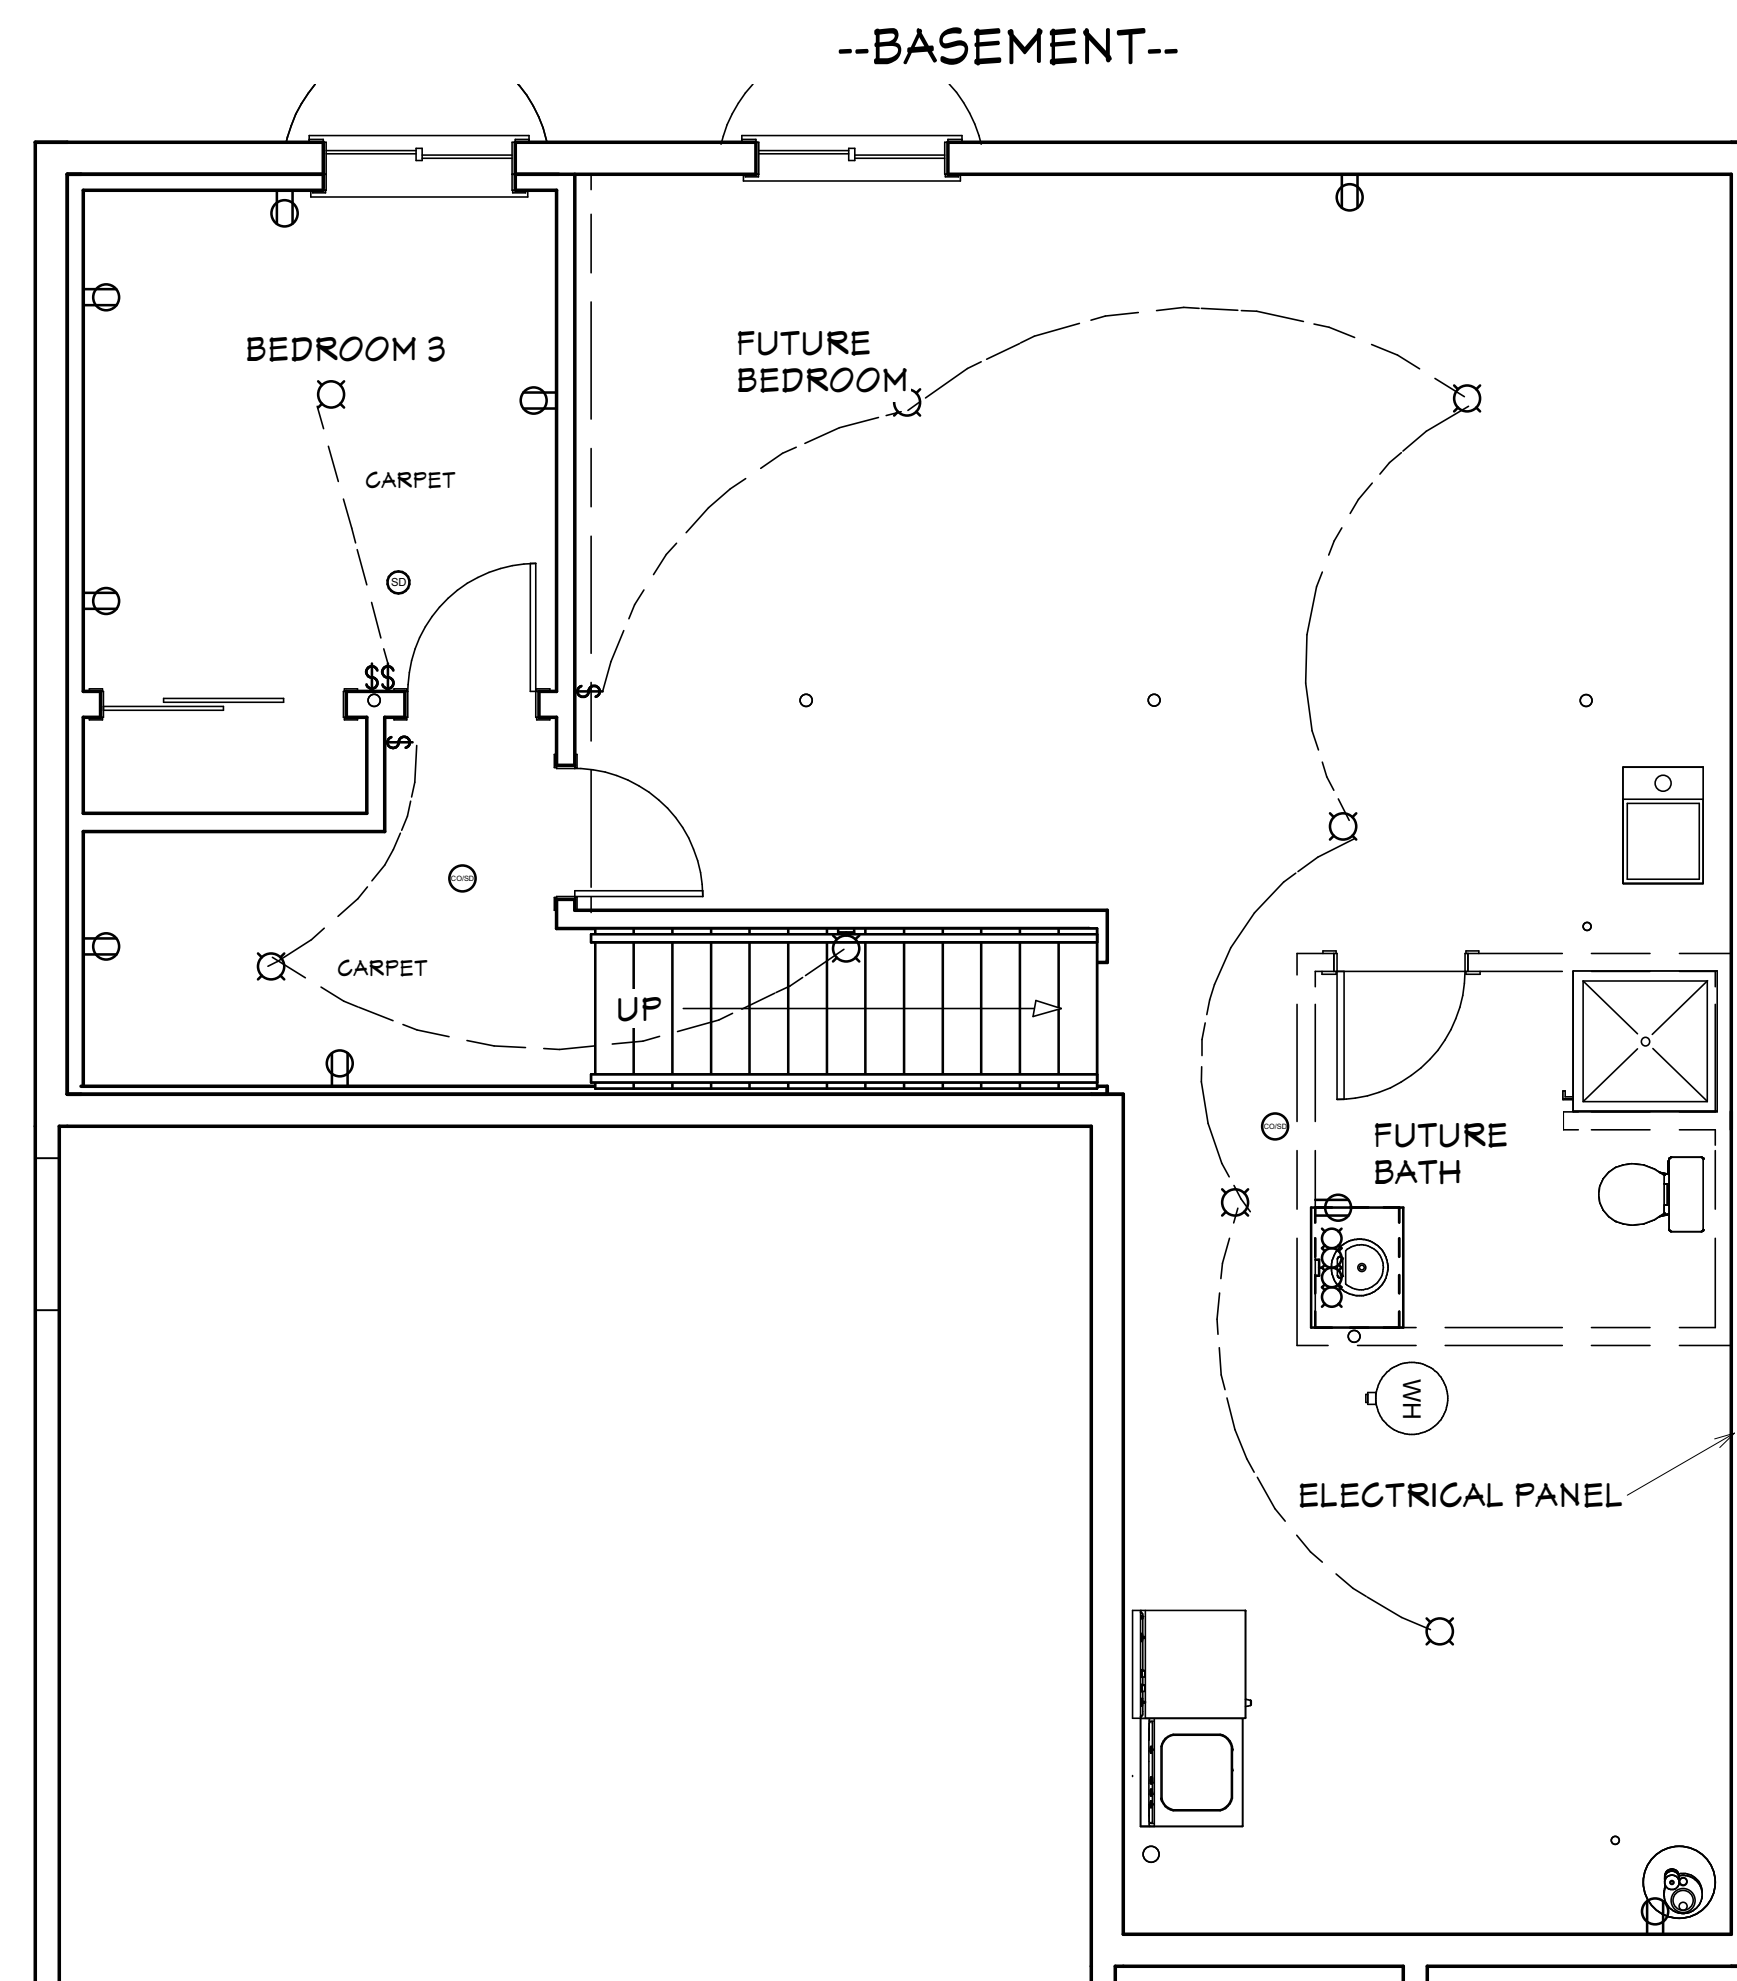

--BASEMENT--

--ELECTRICAL PLAN--



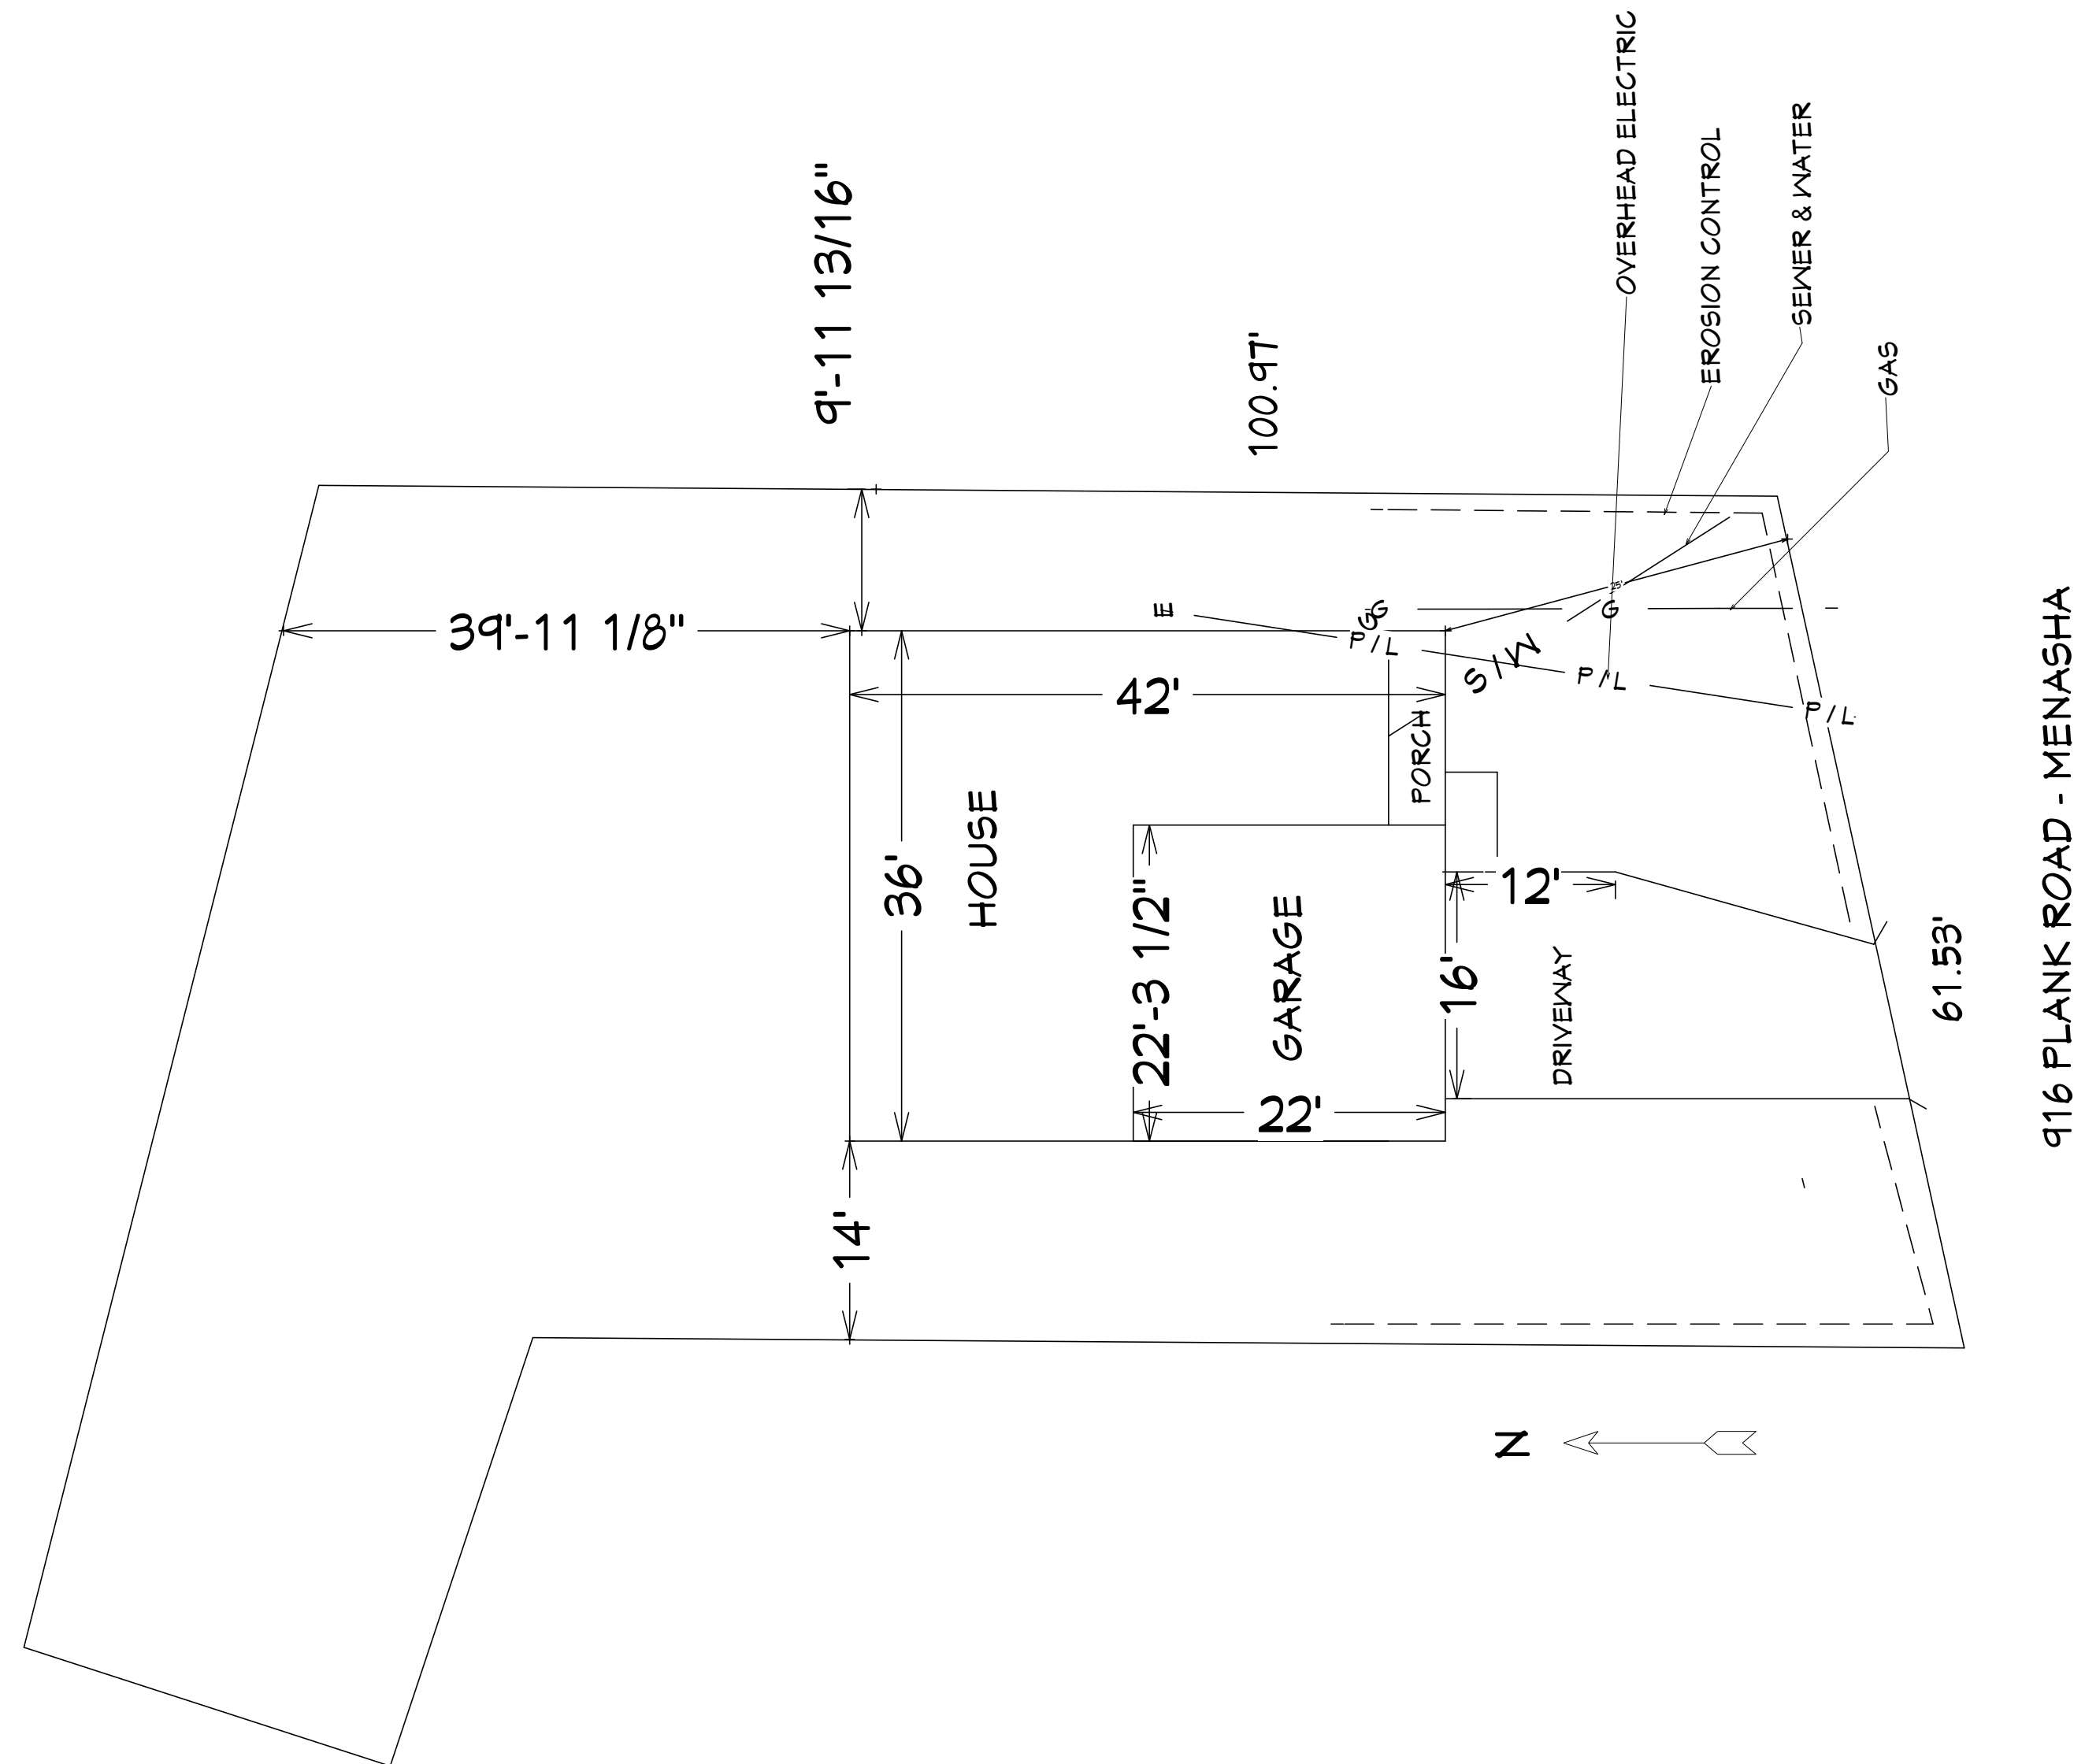

--PLOT PLAN--
SCALE: 3/32" = 1'